


DWG. No.	REFERENCE	REV. No.

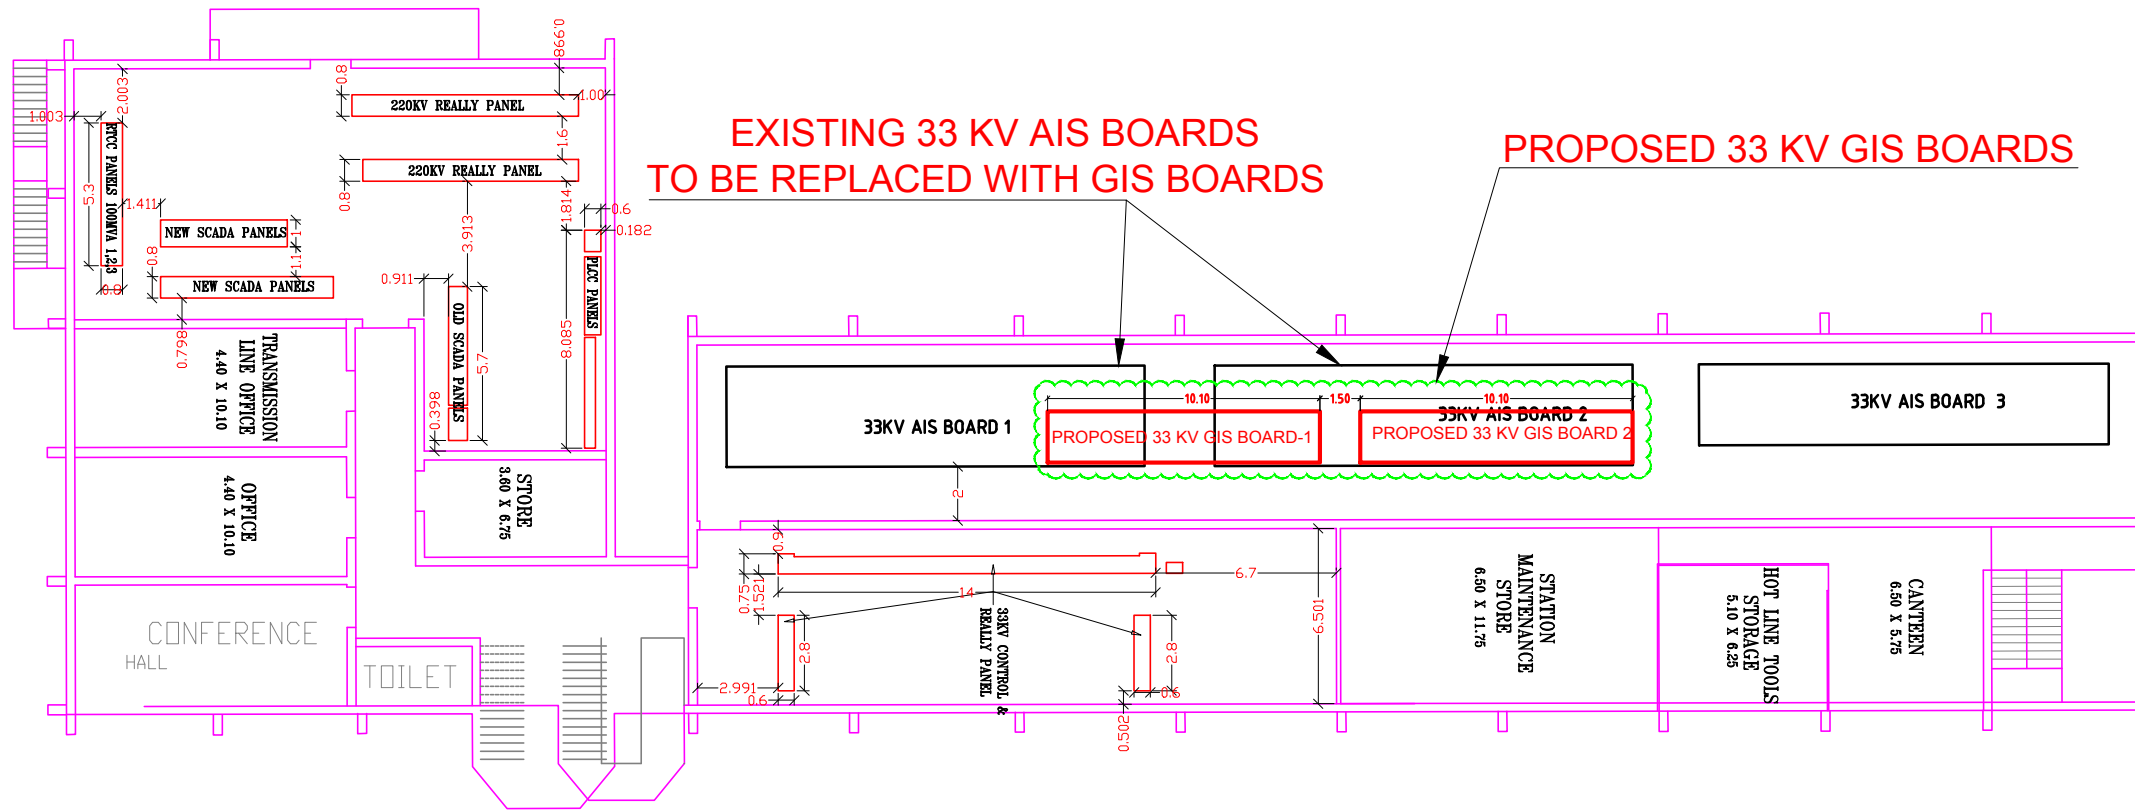

FIRST FLOOR PLAN

220 kV GHODBUNDER EHV SUBSTATION

P2	JK	AMW	FOR DPR PURPOSE	18	06	19
P1	JK	AMW	FOR DPR PURPOSE	01	10	18
P0	JK	AMW	FOR DPR PURPOSE	04	05	17
REV	BY	APPD	DESCRIPTION	DA	MO	YR
APPROVED: AMW			DRAWN : CS	18	06	19
DATE : 18.06.2019			CHECK : JK	18	06	19
SCALE : N.T.S.			DESIGN : JK	18	06	19
A3			DES. CHK : AMW	18	06	19
			CAD FILE :			



220 KV Aarey Receiving Station,
Dinkar Desai Road Goregaon (E) Mumbai 65

CONSULTANT	
PROJECT	33KV AIS to GIS Conversion

TITLE	GHODBUNDER
TITLE	FIRST FLOOR PLAN FOR PROPOSED 33KV GIS BOARD

DWG.	REV P2
------	----------